


**SECTION 10.2.5  
DELAWARE RIVER REGULATOR &  
LOWER MUD RUN METER STATION**

N:\PROJECTS\REGIONAL\_ENERGY\_ACCESS\DELAWARE\_RIVER\_REGULATOR & LOWER\_MUD\_RUN\_M&R\401\_ProjectLocationMapping\_01182021.mxd



- Water Resources Investigation Area
- Delineated Channel (Culverted)
- Floodway
- Limits of Disturbance
- Watershed Boundary

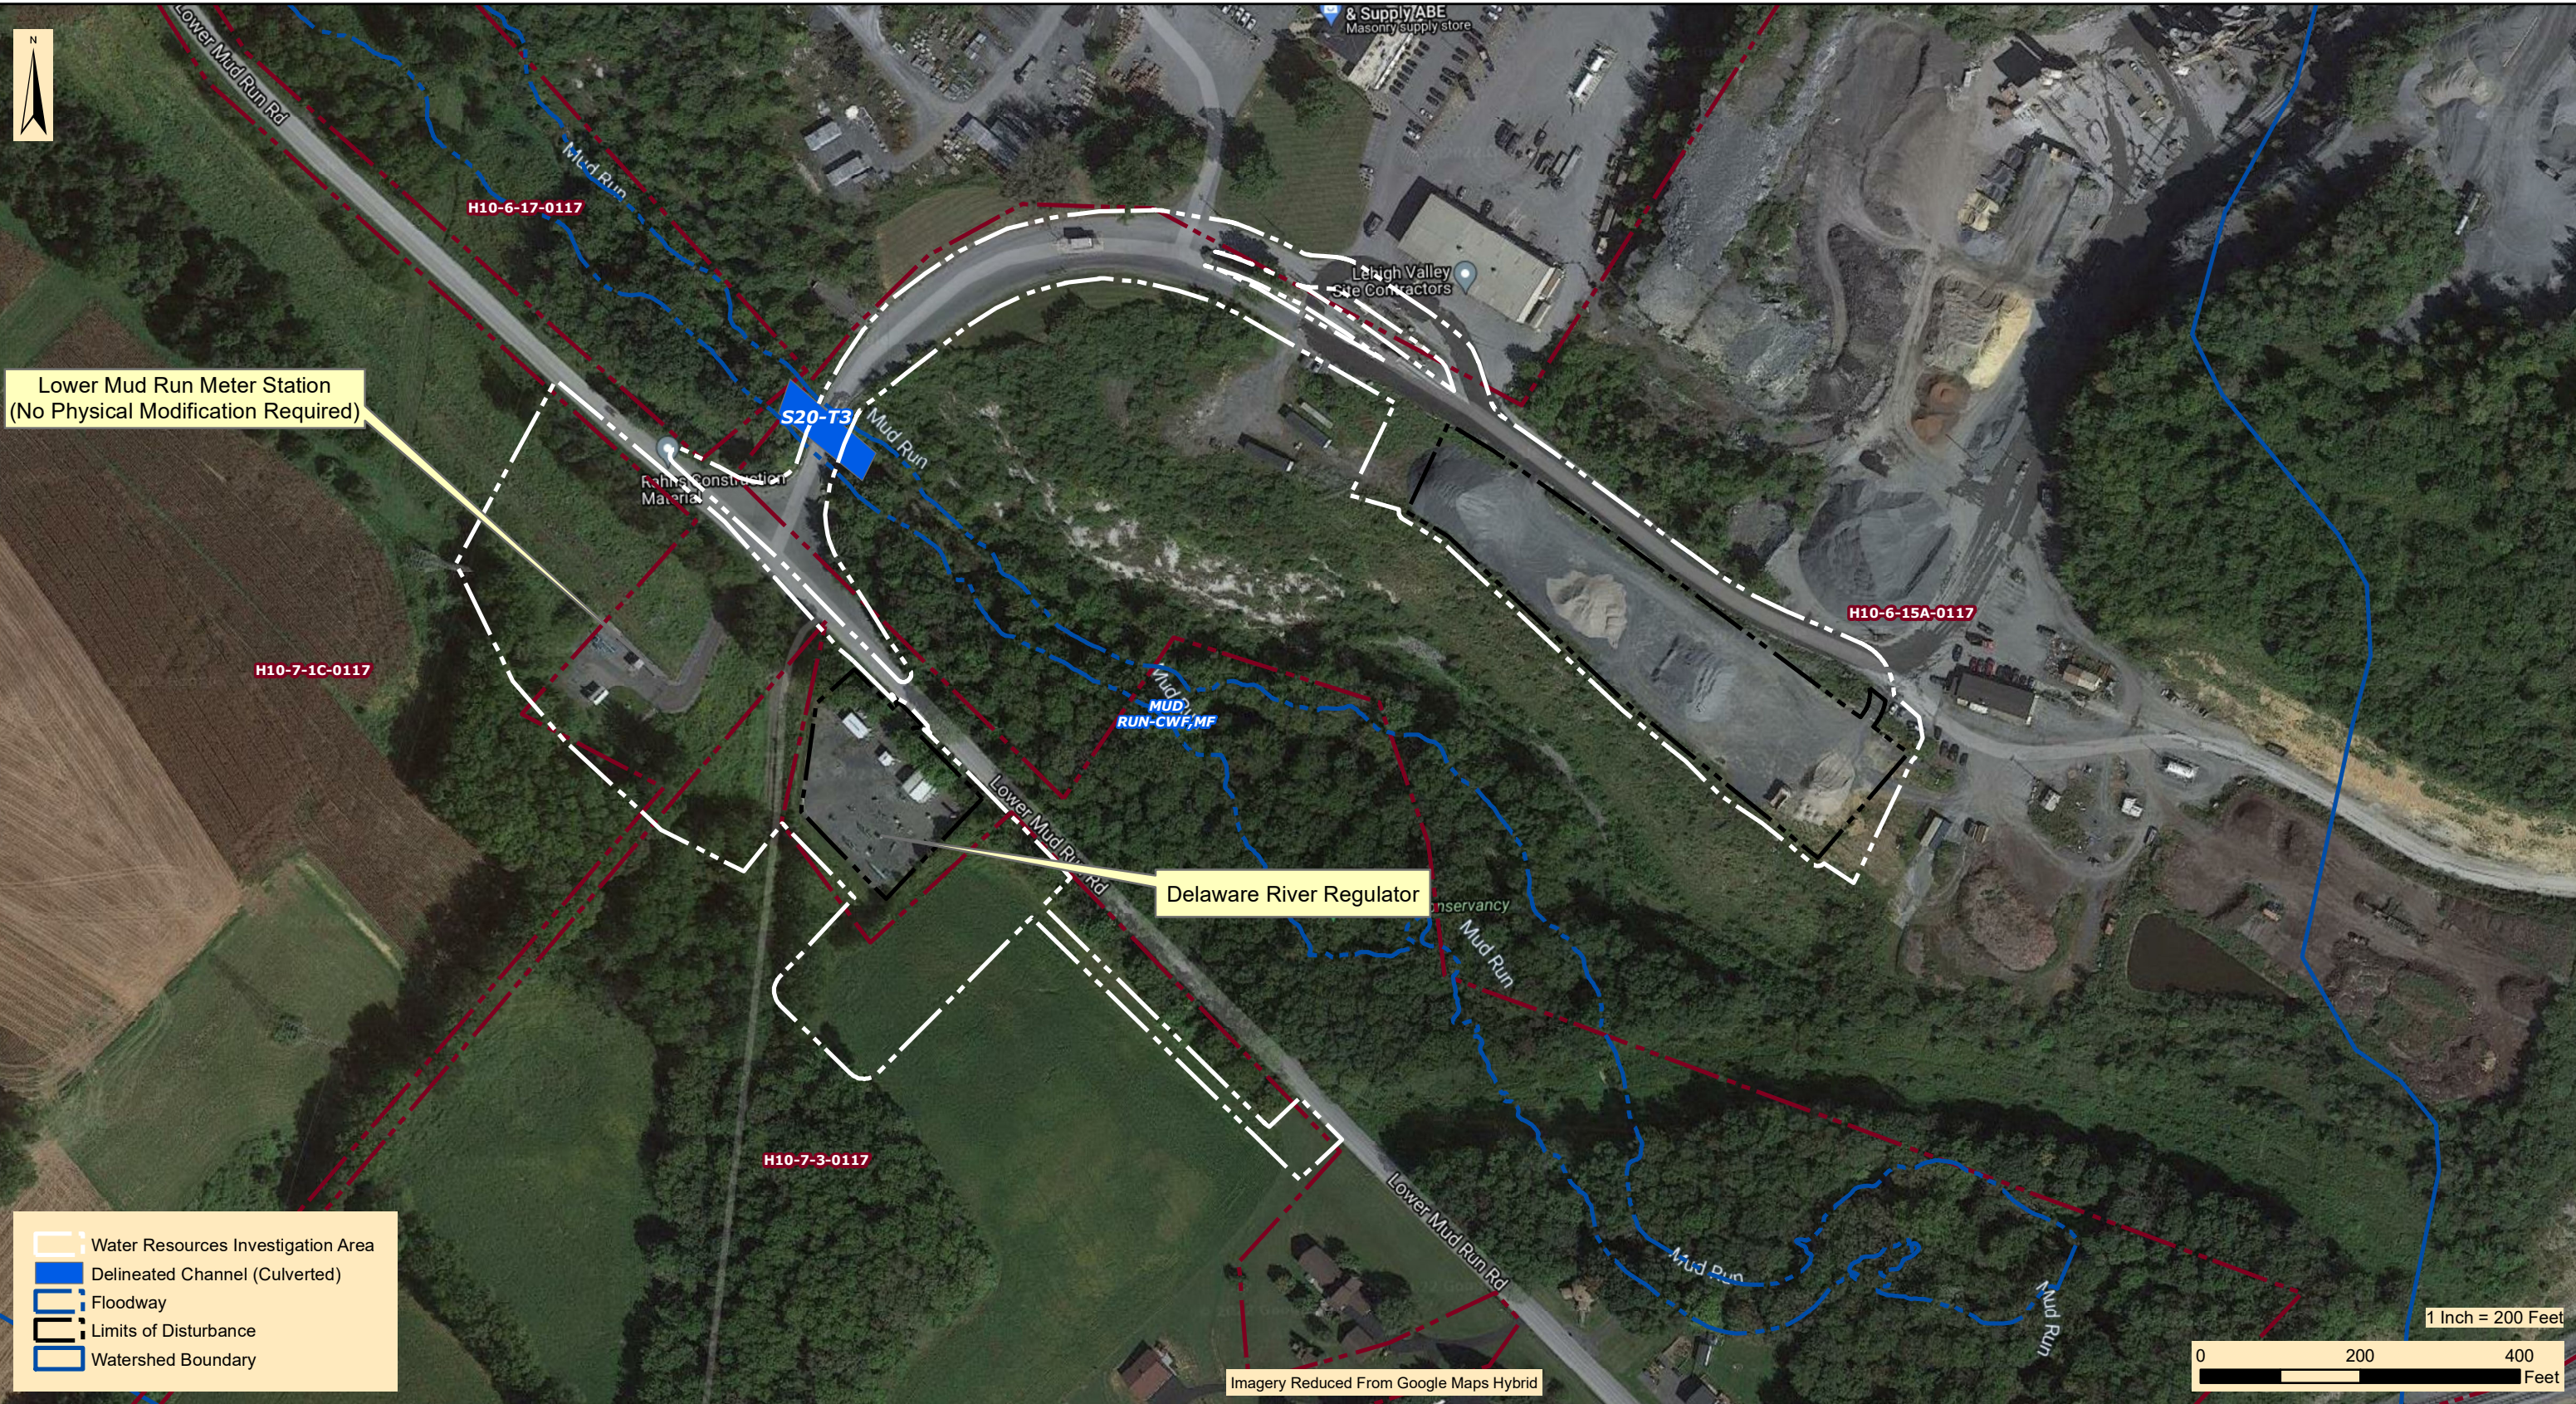

**TRANSCONTINENTAL GAS PIPE LINE COMPANY, LLC**  
**REGIONAL ENERGY ACCESS EXPANSION PROJECT**  
**DELAWARE RIVER REGULATOR & LOWER MUD RUN METER STATION**  
**SITE PLANS**

LOWER MT. BETHEL TOWNSHIP

NORTHAMPTON COUNTY

PENNSYLVANIA

Date:	2/18/2022
Drawn By:	FTN
Figure Number:	1