

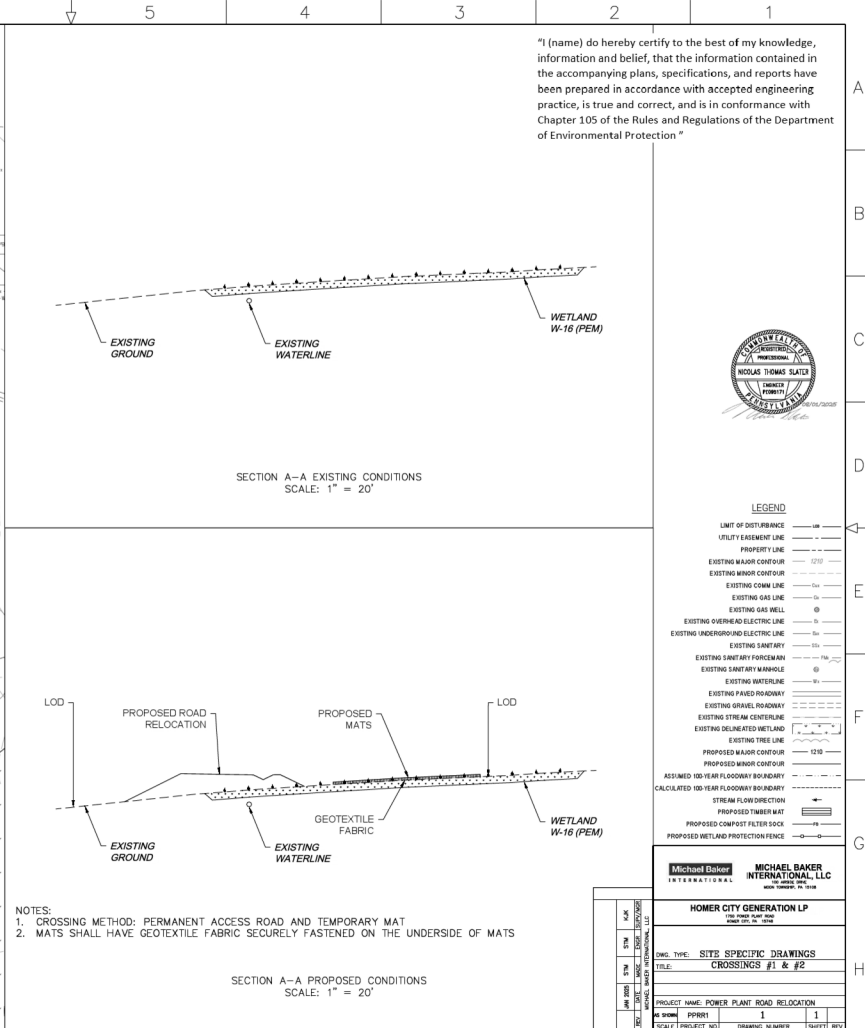
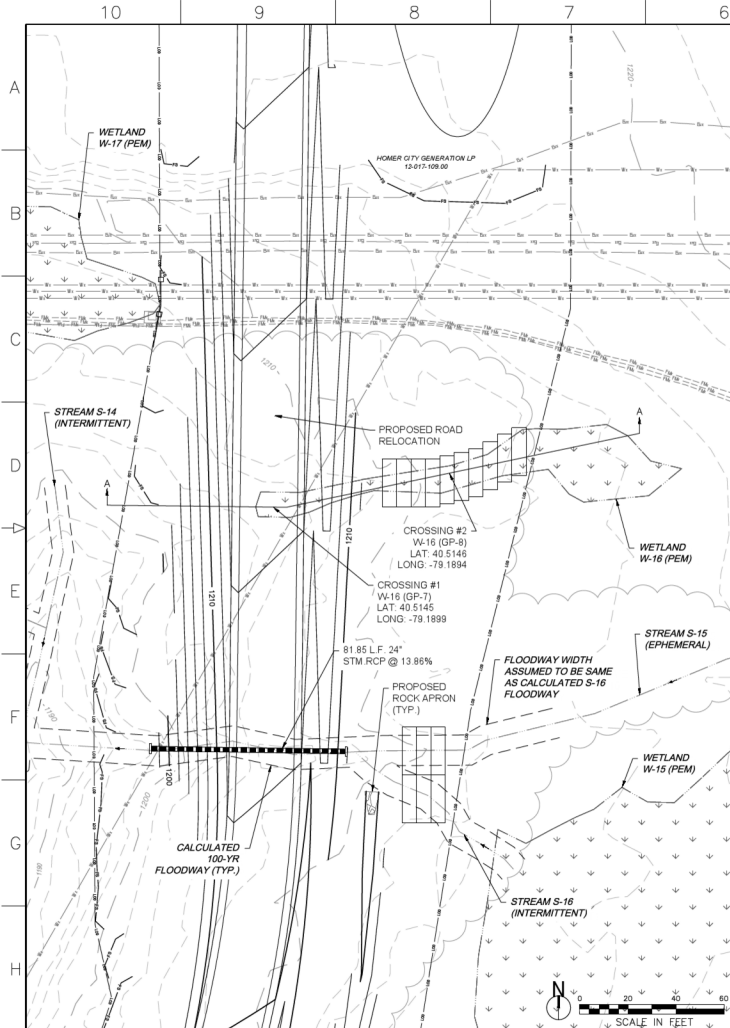


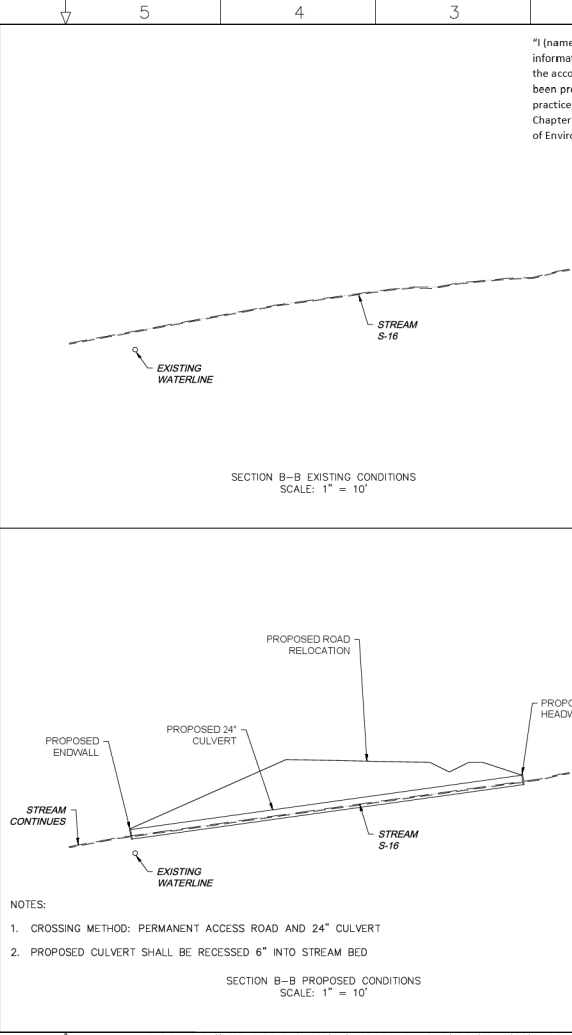

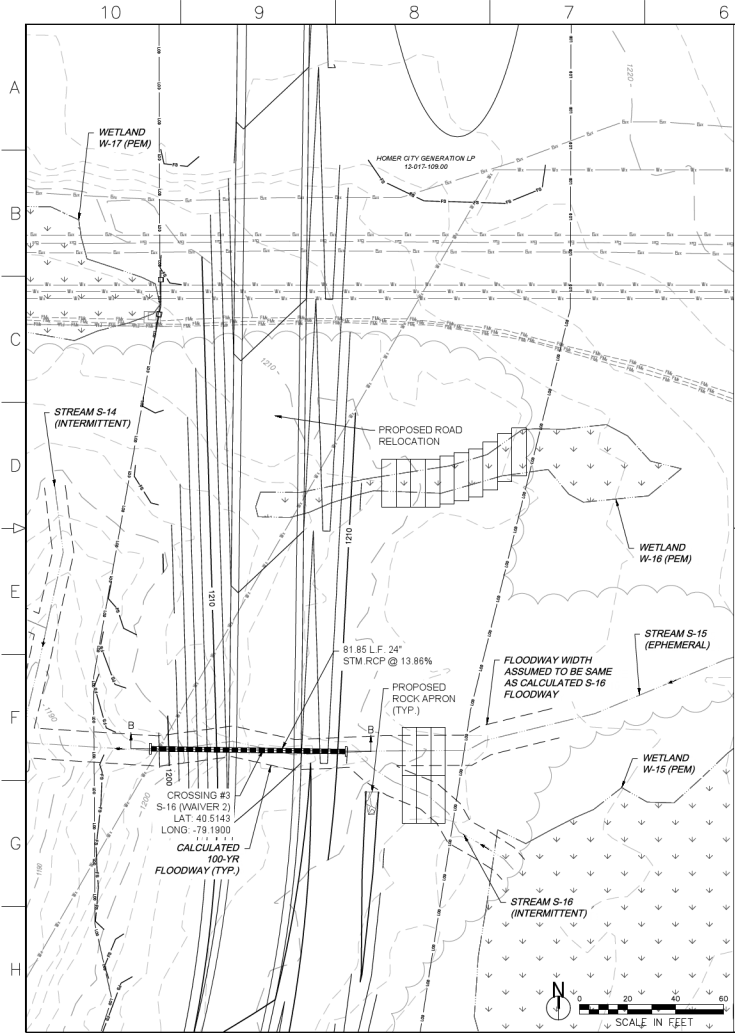

"I (name) do hereby certify to the best of my knowledge, information and belief, that the information contained in the accompanying plans, specifications, and reports have been prepared in accordance with accepted engineering practice, is true and correct, and is in conformance with Chapter 105 of the Rules and Regulations of the Department of Environmental Protection "

LEGEND

- LIMIT OF DISTURBANCE
- UTILITY EASEMENT LINE
- PROPERTY LINE
- EXISTING MAJOR CONTOUR
- EXISTING MINOR CONTOUR
- EXISTING CORN LINE
- EXISTING GAS LINE
- EXISTING GAS WELL
- EXISTING OVERHEAD ELECTRIC LINE
- EXISTING UNDERGROUND ELECTRIC LINE
- EXISTING SANITARY
- EXISTING SANITARY FORCE MAIN
- EXISTING SANITARY MANHOLE
- EXISTING WATERLINE
- EXISTING GRAVEL ROADWAY
- EXISTING STREAM CENTERLINE
- EXISTING TREE LINE
- PROPOSED MAJOR CONTOUR
- PROPOSED MINOR CONTOUR
- ASSUMED 100-YEAR FLOODWAY BOUNDARY
- CALCULATED 100-YEAR FLOODWAY BOUNDARY
- STREAM FLOW DIRECTION
- PROPOSED TRIMMER MAT
- PROPOSED COMPOST FILTER SOCK
- PROPOSED WETLAND PROTECTION FENCE




Michael Baker International, LLC
10000 W. 12th Ave., Suite 200
Boulder, CO 80501
303.440.1000
www.mbakercorp.com

HOMER CITY GENERATION LP
12-017-109.00

DWG. TYPE: SITE SPECIFIC DRAWINGS
TITLE: CROSSING #3

PROJECT NAME: POWER PLANT ROAD RELOCATION
SCALE: PROJECT 1"=10' DRAWING NUMBER: 2 SHEET: 2

HOMER CITY CAD FILE: \\MOONPAT\G\LIB\MBA\CORP\COM\LIB\HOMER CITY GENERATING STATION\DRG\DWG\DRAWINGS\PLT\POWER PLANT ROAD RELOCATION\2020\PPR1-2.DWG
DATE: 06/27/2020 10:30 AM

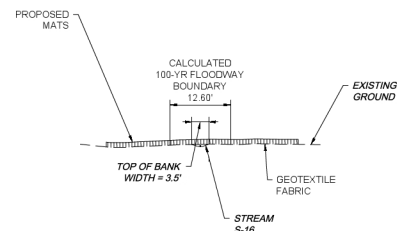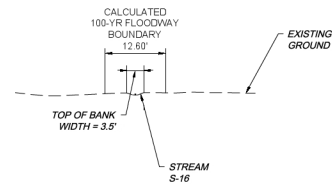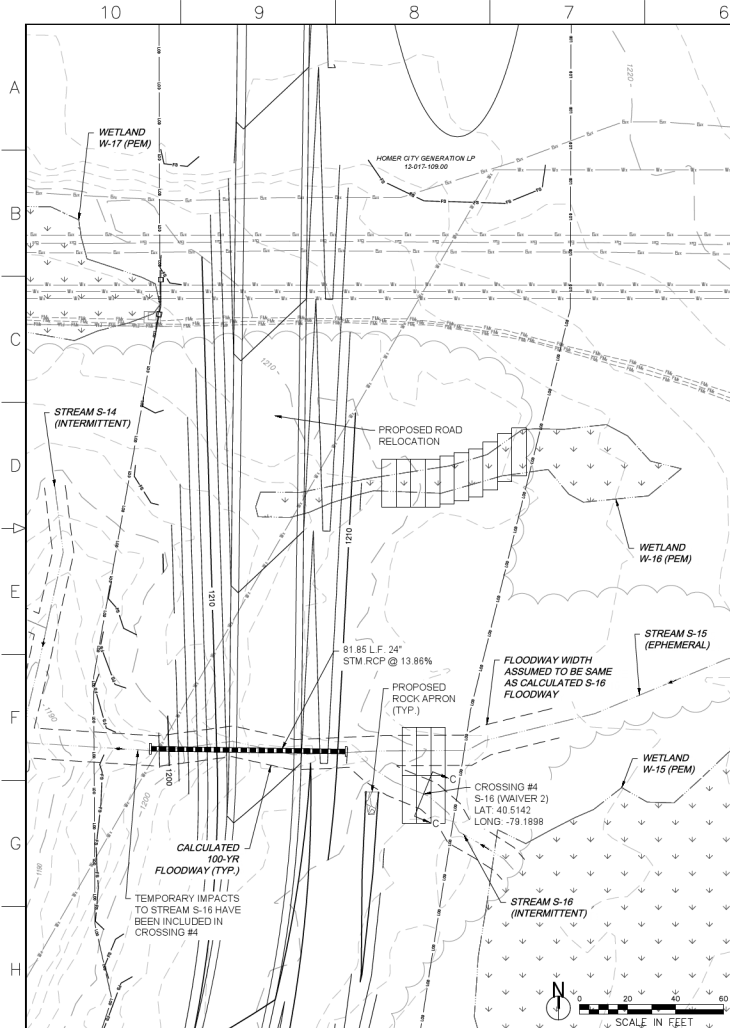

- NOTES:
1. CROSSING METHOD: TEMPORARY MAT
 2. MATS SHALL HAVE GEOTEXTILE FABRIC SECURELY FASTENED ON THE UNDERSIDE OF MATS


LEGEND

- LIMIT OF DISTURBANCE ----- 1/8"
- UTILITY EASEMENT LINE -----
- PROPERTY LINE -----
- EXISTING MAJOR CONTOUR ----- 1/2"
- EXISTING MINOR CONTOUR -----
- EXISTING CONDUIT LINE -----
- EXISTING GAS LINE -----
- EXISTING GAS WELL (X)
- EXISTING OVERHEAD ELECTRIC LINE -----
- EXISTING UNDERGROUND ELECTRIC LINE -----
- EXISTING SANITARY -----
- EXISTING SANITARY FORCEMAIN -----
- EXISTING SANITARY BRANCH -----
- EXISTING WATERLINE -----
- EXISTING PAVED ROADWAY -----
- EXISTING GRAVEL ROADWAY -----
- EXISTING STREAM COURSE -----
- EXISTING DELIMITED WETLAND -----
- EXISTING TREE LINE -----
- PROPOSED MAJOR CONTOUR ----- 1/2"
- PROPOSED MINOR CONTOUR -----
- ASSUMED 100-YEAR FLOODWAY BOUNDARY -----
- CALCULATED 100-YEAR FLOODWAY BOUNDARY -----
- STREAM FLOW DIRECTION ----->
- PROPOSED TRENCH MARK -----
- PROPOSED COMPACT FILTER SOCK -----
- PROPOSED WETLAND PROTECTION FENCE -----


						Michael Baker INTERNATIONAL		MICHAEL BAKER INTERNATIONAL, LLC 100 NORTH PLANT AVENUE SUITE 1000, WYOMING, NY 10986	
						HOMER CITY GENERATION LP			
						THE POWER PLANT AND HOMER CITY, NY - HOMER			
						DRG. TYPE SITE SPECIFIC DRAWINGS TITLE CROSSING #4			
						PROJECT NAME: POWER PLANT ROAD RELOCATION			
						NO WORK PPSR#1 3			
						SCALE PROJECT NO. DRAWING NUMBER SHEET REV			

Road Relocation/202203_PPSR_OP Site PLAN/DWG Plot Date:6/27/2025 8:36 AM


HOMER CITY CAD FILE: \\MOONPA1CL1.BKR.MBAKRCORP.COM\LD\HOMER CITY GENERATING STATION\06_CIVIL\DRAWINGS\LOT\POWER PLANT ROAD RELOCATION\202265_PRR_OP SITE PLAN.DWG PLOT DATE:6/27/2025 8:38 AM

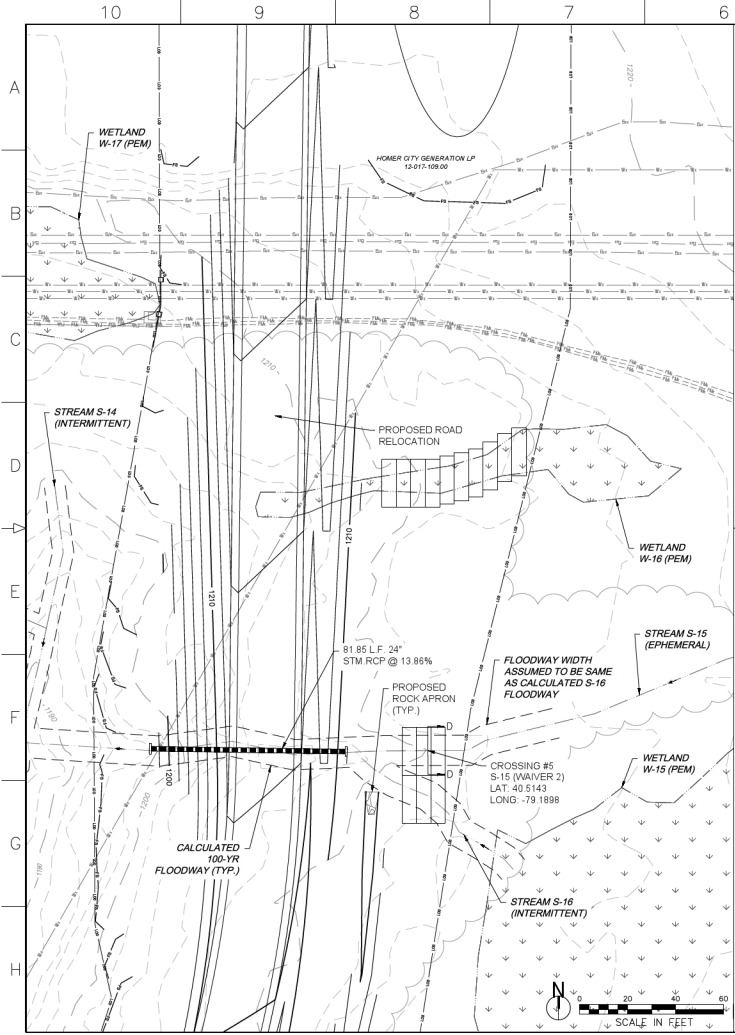

- NOTES:
1. CROSSING METHOD: TEMPORARY MAT
 2. MATS SHALL HAVE GEOTEXTILE FABRIC SECURELY FASTENED ON THE UNDERSIDE OF MATS

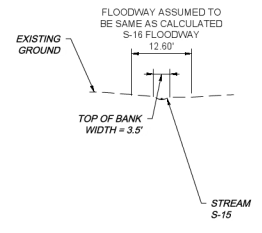

SECTION D-D EXISTING CONDITIONS
SCALE: 1" = 10'

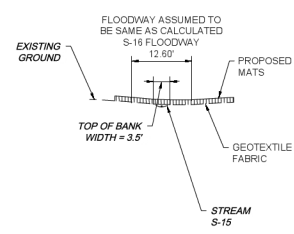

SECTION D-D PROPOSED CONDITIONS
SCALE: 1" = 10'

"I (name) do hereby certify to the best of my knowledge, information and belief, that the information contained in the accompanying plans, specifications, and reports have been prepared in accordance with accepted engineering practice, is true and correct, and is in conformance with Chapter 105 of the Rules and Regulations of the Department of Environmental Protection "



LEGEND

--- 10'	LIMIT OF DISTURBANCE
---	UTILITY EASEMENT LINE
---	PROPERTY LINE
---	EXISTING MAJOR CONTOUR
---	EXISTING MINOR CONTOUR
---	EXISTING CORN LINE
---	EXISTING GAS LINE
---	EXISTING GAS WELL
---	EXISTING OVERHEAD ELECTRIC LINE
---	EXISTING UNDERGROUND ELECTRIC LINE
---	EXISTING SANITARY
---	EXISTING SANITARY FORCE MAIN
---	EXISTING SANITARY MANHOLE
---	EXISTING WATERLINE
---	EXISTING PAVED ROADWAY
---	EXISTING GRAVEL ROADWAY
---	EXISTING STREAM CENTERLINE
---	EXISTING TREE LINE
---	PROPOSED MAJOR CONTOUR
---	PROPOSED MINOR CONTOUR
---	ASSUMED 100-YEAR FLOODWAY BOUNDARY
---	CALCULATED 100-YEAR FLOODWAY BOUNDARY
---	STREAM FLOW DIRECTION
---	PROPOSED TIMBER MAT
---	PROPOSED COMPOST FILTER SOCK
---	PROPOSED WETLAND PROTECTION FENCE

Michael Baker International		MICHAEL BAKER INTERNATIONAL, L.L.C.	
HOMER CITY GENERATION LP			
DWG. TYPE: SITE SPECIFIC DRAWINGS			
TITLE: CROSSING #5			
PROJECT NAME: POWER PLANT ROAD RELOCATION			
AS SHOWN	PPRRI	4	4
SCALE	PROJECT NO.	DRAWING NUMBER	SHEET NO.