


LEBANON COUNTY, PENNSYLVANIA - SOUTH LONDONDERRY TOWNSHIP S3-0100

PROFILE VIEW

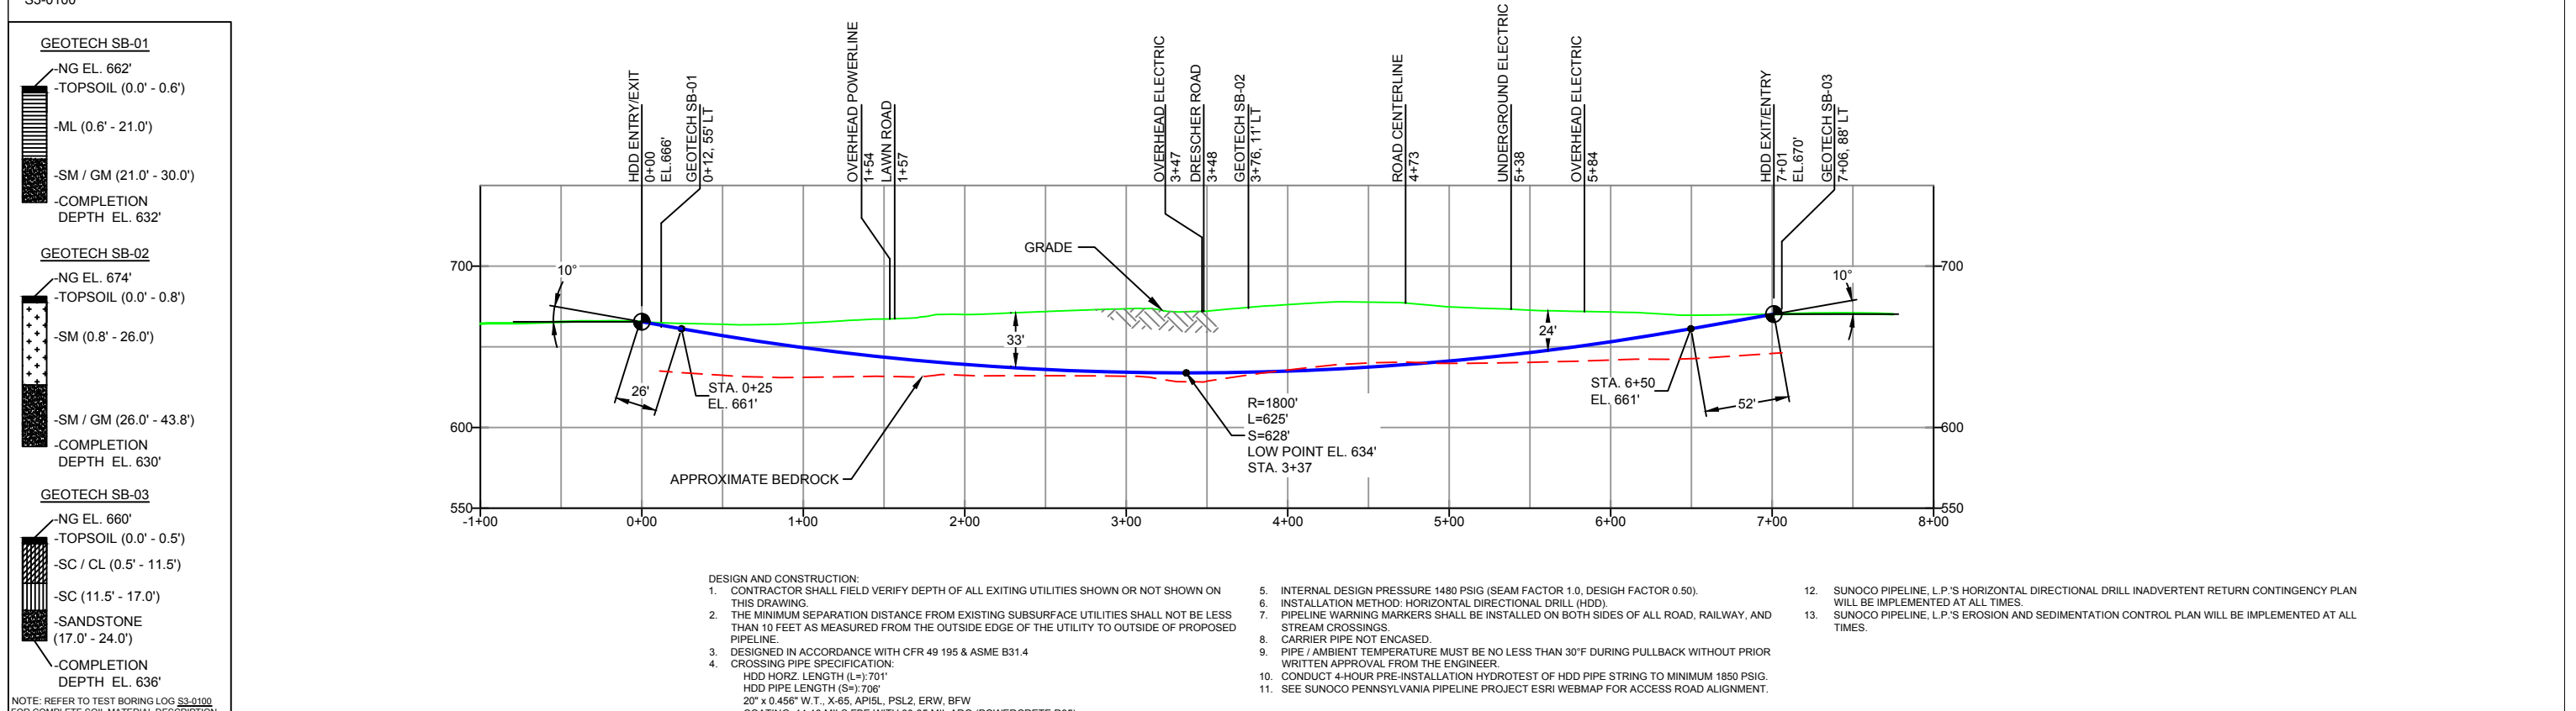

NOTES				REF. DRAWING				REVISIONS						SUNOCO PIPELINE, L.P.			
1. ALL COORDINATES SHOWN ARE IN LATITUDE AND LONGITUDE. ALL MSL ELEVATIONS ARE NAD83 2. STATIONING IS BASED ON HORIZONTAL DISTANCES 3. ROONEY ENGINEERING, INC. AND SUNOCO PIPELINE, LP ARE NOT RESPONSIBLE FOR LOCATION OF FOREIGN UTILITIES SHOWN IN PLOT PLAN OR PROFILE. THE INFORMATION SHOWN HEREON IS FURNISHED WITHOUT LIABILITY ON THE PART OF ROONEY ENGINEERING, INC. AND SUNOCO PIPELINE, LP, FOR ANY DAMAGES RESULTING FROM ERRORS OR OMISSIONS THEREIN. 4. CONTRACTOR IS RESPONSIBLE FOR LOCATING ALL UTILITIES. CONTACT ONE CALL AT 811 PRIOR TO DIGGING. 5. SUNOCO EMERGENCY HOTLINE NUMBER IS #1-800-786-7440.				ES-5.04	TO	ES-5.05	EROSION & SEDIMENT PLAN	EP1	REVISED PER PADEP COMMENTS	JTW	05/11/16	RMB	05/11/16	AAW	05/11/16	SUNOCO PIPELINE, L.P. 20-INCH HORIZONTAL DIRECTIONAL DRILL LAWN ROAD PENNSYLVANIA PIPELINE PROJECT	
				SHEET 3	TO	SHEET 3	AERIAL SITE PLAN	EP		MRS	02/26/16	RMB	02/26/16	AAW	02/26/16		
								C	ADDED GEOTECH INFO	MRS	09/22/15	RMB	09/22/15	AAW	09/22/15		
								B	ISSUED FOR BID	MRS	07/31/15	RMB	07/31/15	AAW	07/31/15		
								A	ISSUED FOR REVIEW	JVA	04/15/15	RMB	04/15/15	AAW	04/15/15		
				DWG NO		DWG NO	DESCRIPTION	NO.	DESCRIPTION	BY	DATE	CHK	DATE	APP	DATE		

Sunoco Logistics Partners L.P.

TETRA TECH ROONEY
(303) 792-5911

SCALE: 1"=100' DWG. NO: PA-LE-0009.0000-RD