


PROFILE VIEW

CAMBRIA COUNTY, PENNSYLVANIA - MUNSTER TOWNSHIP
S2-0080

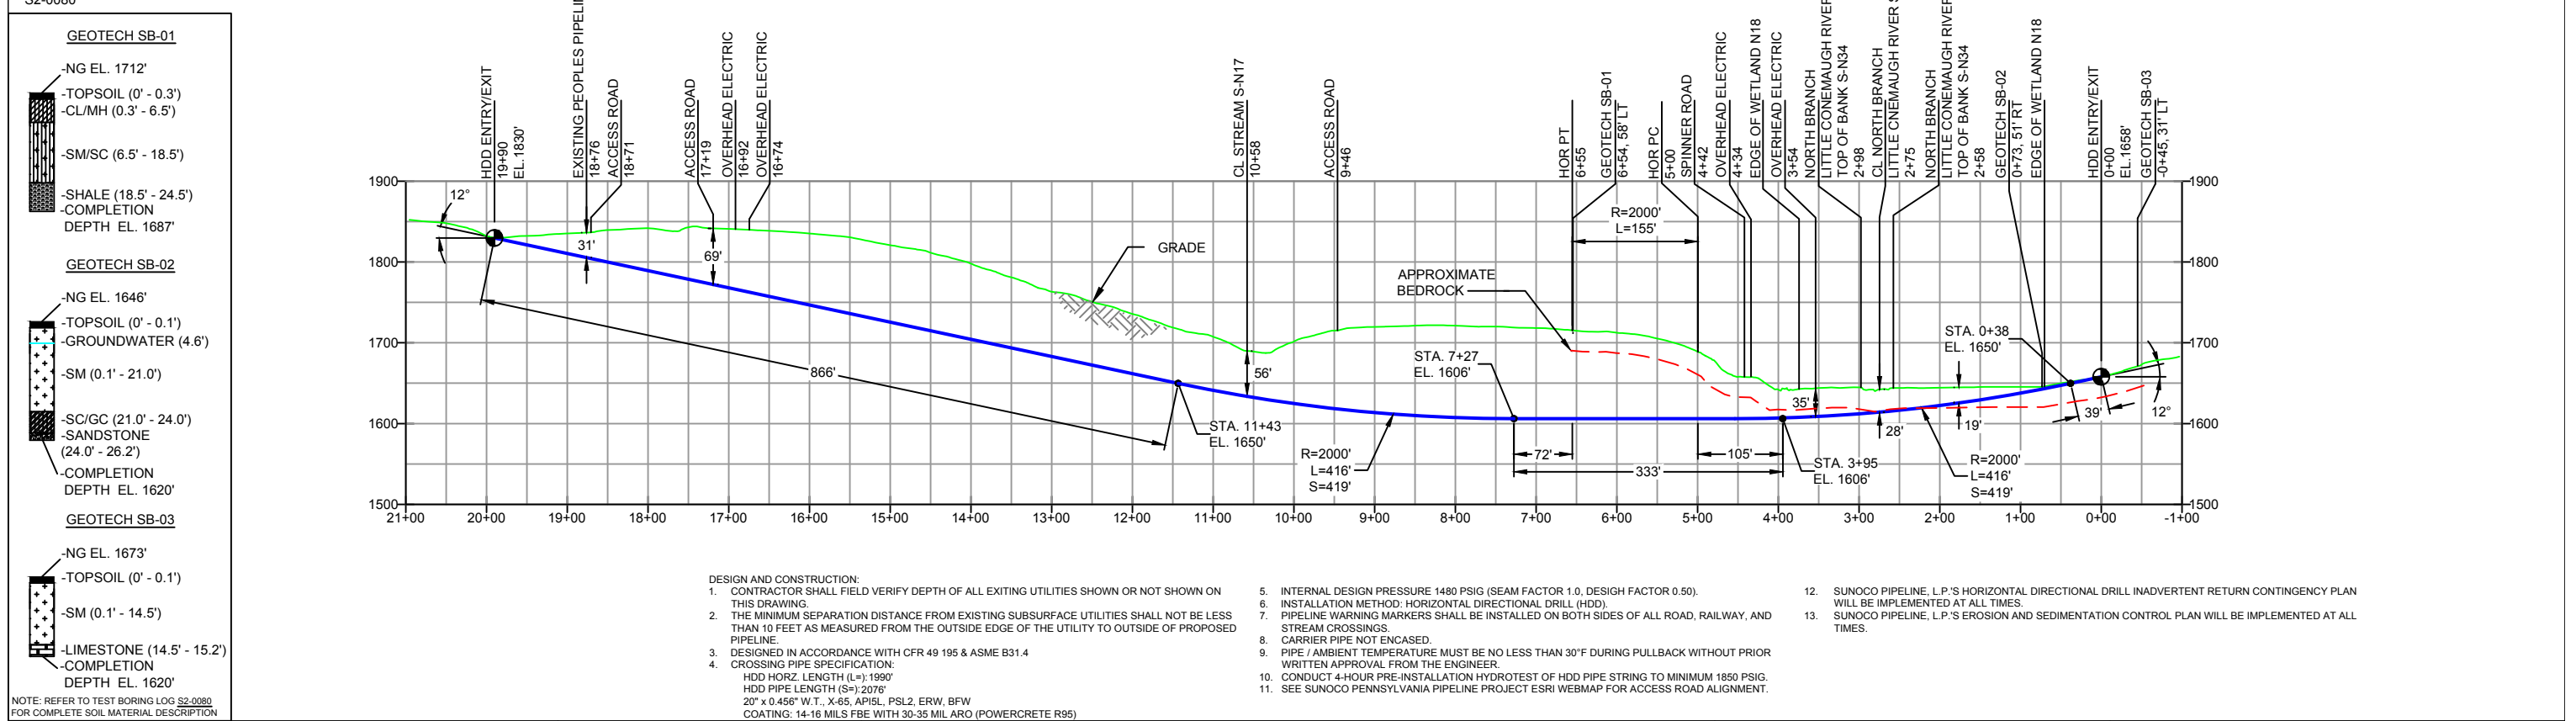

NOTES				REF. DRAWING				REVISIONS						SUNOCO PIPELINE, L.P.				
1. ALL COORDINATES SHOWN ARE IN LATITUDE AND LONGITUDE. ALL MSL ELEVATIONS ARE NAD83				ES-2.47	TO	ES-2.48	EROSION & SEDIMENT PLAN											
2. STATIONING IS BASED ON HORIZONTAL DISTANCES				SHEET 29	TO	SHEET 30	AERIAL SITE PLAN	EP1	REVISED PER PADEP COMMENTS									
3. ROONEY ENGINEERING, INC. AND SUNOCO PIPELINE, LP ARE NOT RESPONSIBLE FOR LOCATION OF FOREIGN UTILITIES SHOWN IN PLOT PLAN OR PROFILE. THE INFORMATION SHOWN HEREON IS FURNISHED WITHOUT LIABILITY ON THE PART OF ROONEY ENGINEERING, INC. AND SUNOCO PIPELINE, LP, FOR ANY DAMAGES RESULTING FROM ERRORS OR OMISSIONS THEREIN.								EP	JTW	05/18/16	RMB	05/18/16	AAW	05/18/16				
4. CONTRACTOR IS RESPONSIBLE FOR LOCATING ALL UTILITIES. CONTACT ONE CALL AT 811 PRIOR TO DIGGING.								C	JTW	03/15/16	RMB	03/15/16	AAW	03/15/16				
5. SUNOCO EMERGENCY HOTLINE NUMBER IS #1-800-786-7440.								B	MRS	09/06/15	RMB	09/06/15	AAW	09/06/15				
								A	MRS	07/31/15	DLM	07/31/15	AAW	07/31/15				
DWG NO	DWG NO	DESCRIPTION	NO.	DESCRIPTION	NO.	DESCRIPTION	NO.	DESCRIPTION	BY	DATE	CHK	DATE	APP	DATE				
									RTT	03/27/15	RMB	03/27/15	AAW	03/27/15				

Sunoco Logistics Partners L.P.

TETRA TECH ROONEY
(303) 792-5911

SUNOCO PIPELINE, L.P.

20-INCH HORIZONTAL DIRECTIONAL DRILL
SPINNER ROAD
PENNSYLVANIA PIPELINE PROJECT

SCALE: 1"=200' DWG. NO: PA-CA-0069.0000-RD